
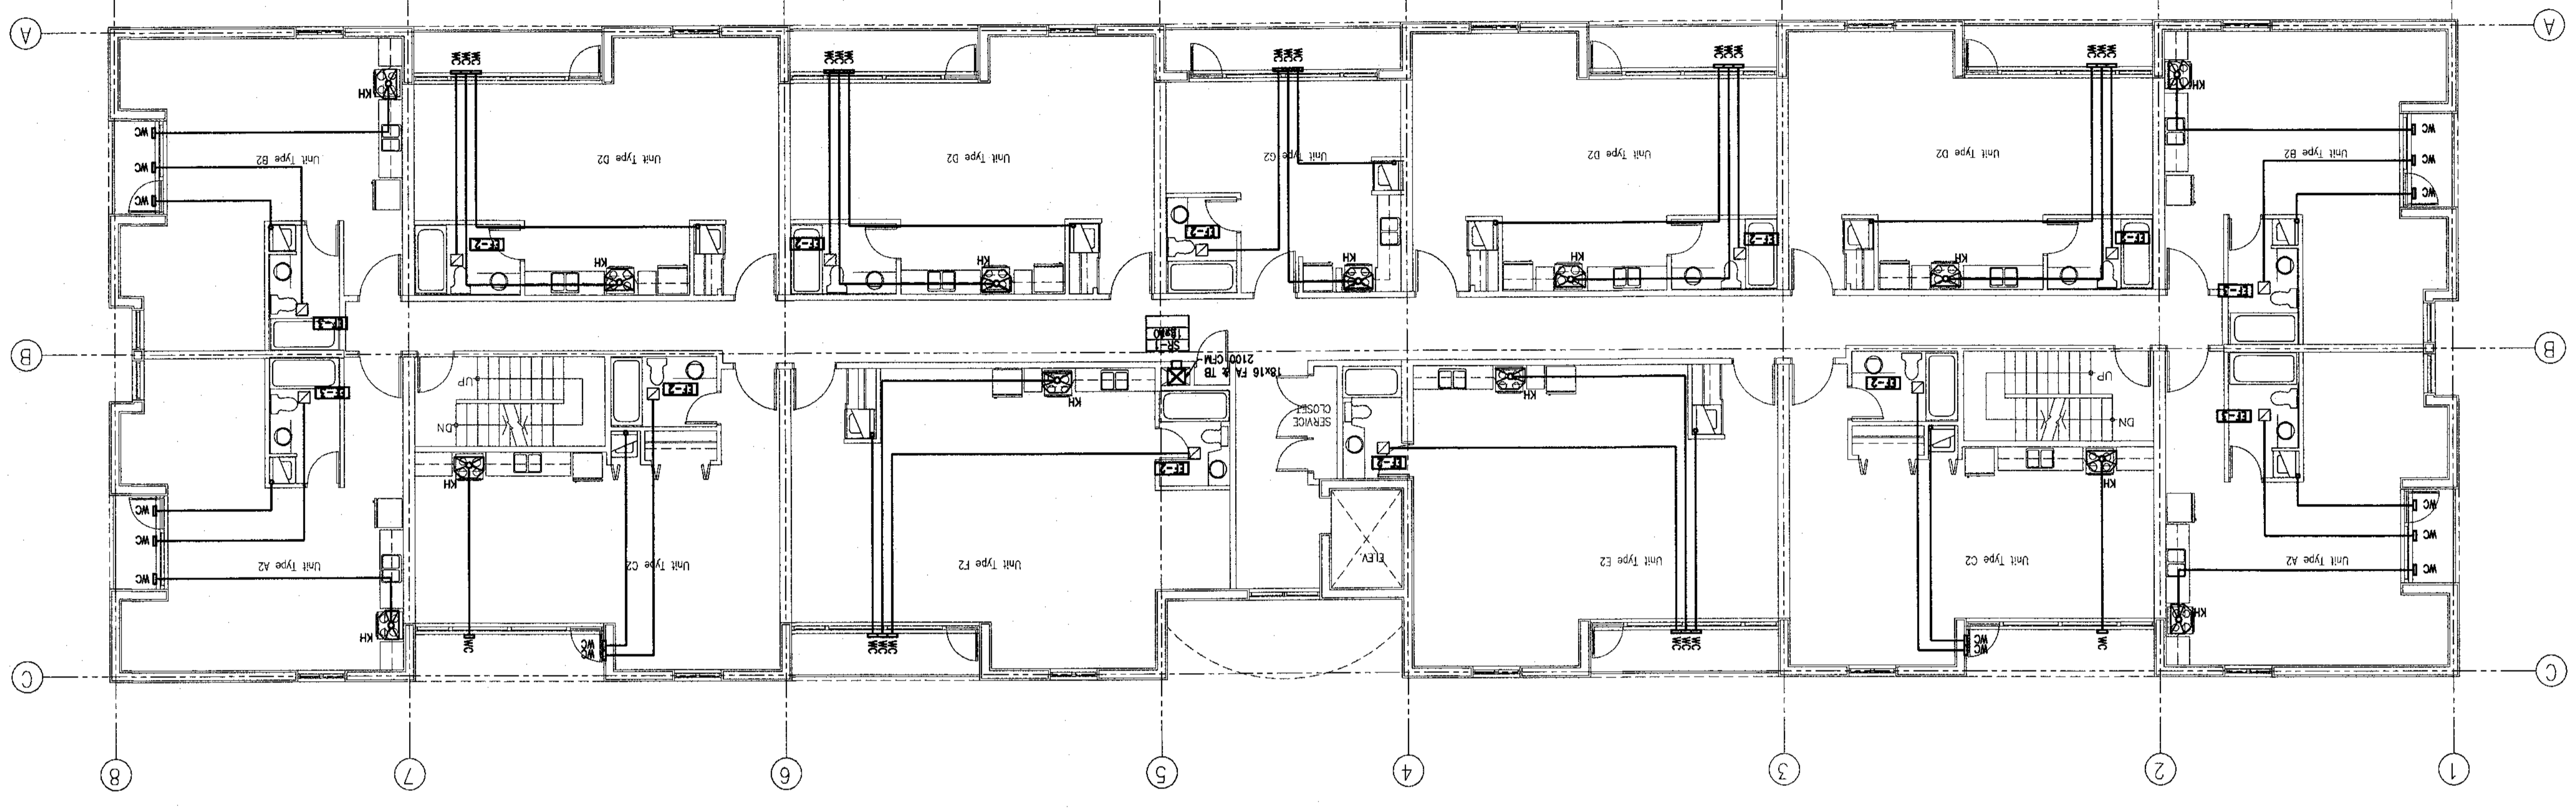


M-9	JOB NO.: 203079	PROJECT TITLE: SECOND & THIRD FLOOR PLANS HVAC	 AVALON MECHANICAL GENERAL CONTRACTORS LTD. 14-1522A Highway 108 Victoria, B.C. V8N 1L1 Tel: 250-413-1134
9 OF 11	DATE: (OWNER) 26MAY03	DESCRIPTION: WILSON MANOR 109 WILSON ST., VICTORIA, B.C.	SHEET NO.: APPROVED BY: DRAWN BY: SCALE: AS NOTED

NO.	DESCRIPTION
1	ISSUED FOR BUILDING PERMIT
2	DATE: (OWNER)

SECOND & THIRD FLOOR TYPICAL PLAN
SCALE 1/8"=1'-0"



- NOTE:**
1. ALL KITCHEN EXHAUST DUCTS = 6"
 2. ALL WASHROOM EXHAUST DUCTS EF-1 = 4"
 3. ALL WASHROOM EXHAUST DUCTS EF-2 = 5"
 4. ALL WASHROOM EXHAUST DUCTS EF-3 = 5"
 5. ALL DRYER EXHAUST DUCTS = 4"
- LEGEND**
- | | |
|---|---|
| <ul style="list-style-type: none"> RECTANGULAR DUCT ROUND SOLID DUCT ROUND SOLID DUCT ACOUSTICALLY LINED DUCT SENSOR LABEL SIZE CFM EXHAUST FAN EF EXHAUST GRILLE EG FROM ABOVE FB FROM BELOW FB FIRE DAMPER FD HALLWAY PRESSURIZATION UNIT HPU TO ABOVE TA TO BELOW TB SOFFIT CAP SC WALL CAP WC | <ul style="list-style-type: none"> SR-1 200 606 200 CFM EF EG FB FD HPU TA TB SC WC |
|---|---|