
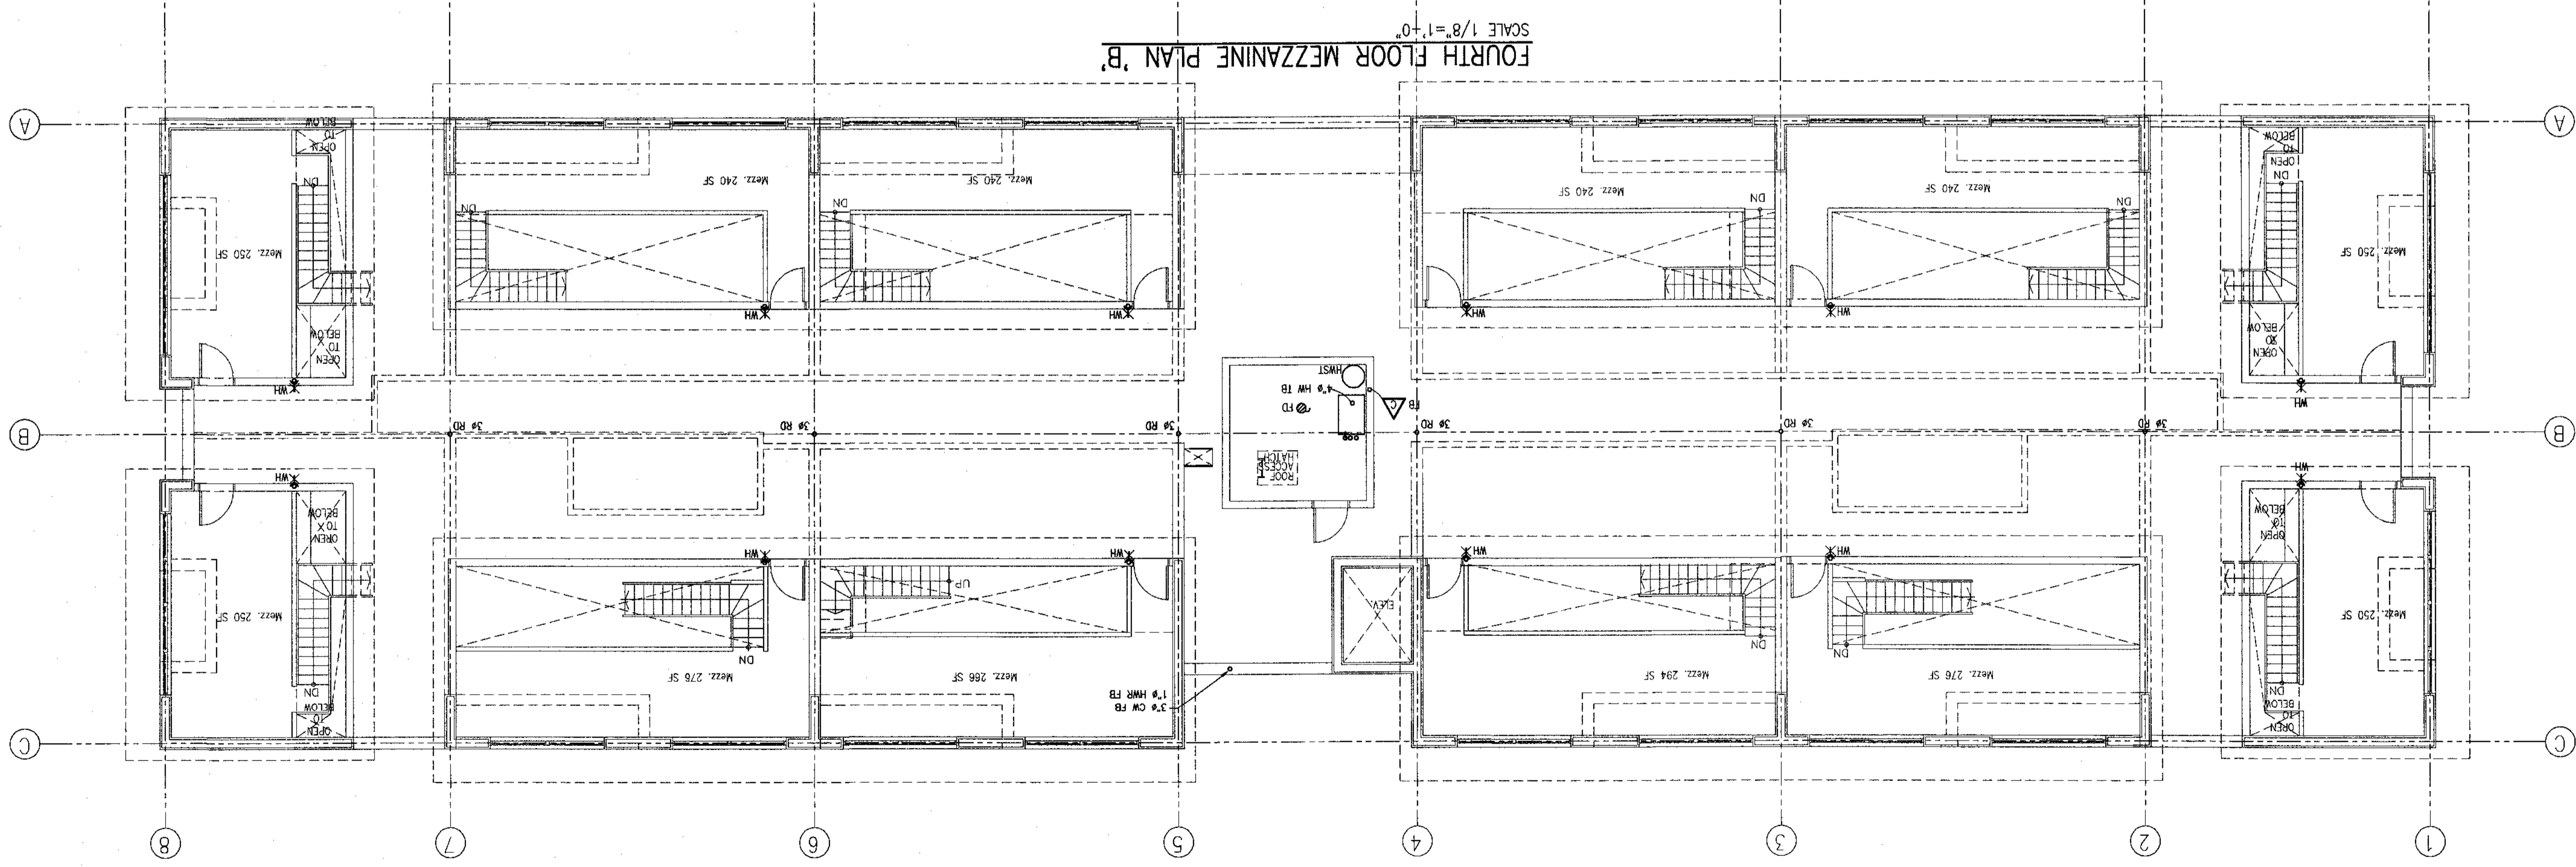


AS NOTED DESIGNED BY: J.E. CHECKED BY: M.D. DATE: 15 OCT 03 JOB NO.: 203079		THE WING 109 WILSON ST., VICTORIA, B.C. FOURTH FLOOR & MEZZANINE PLAN PLUMBING	 4112A DAVENPORT ST. #113 VICTORIA, B.C. V8M 1B3 TEL: 250-383-4133 FAX: 250-383-4138
SHEET: 6 OF 11 DRAWING NO.: M-6			

NO.	DATE (COMMENT)	DESCRIPTION
1	04NOV03	ISSUED FOR BUILDING PERMIT

NOTES:

1. SITE VERIFY EXISTING PIPING, EQUIPMENT, ETC.
2. ALL 6" SEWER & STORM LINES ARE AT A MINIMUM 0.75% SLOPE. ALL 4" SEWER & STORM LINES ARE AT A MINIMUM 1% SLOPE, AND ALL 3" LINES ARE AT A MINIMUM 2% SLOPE UNLESS OTHERWISE INDICATED.
3. ALL GAS LINES SCHEDULE 40 @ 2 PSIG +/- 1 PSIG AND @ 1/2" UNLESS OTHERWISE INDICATED.

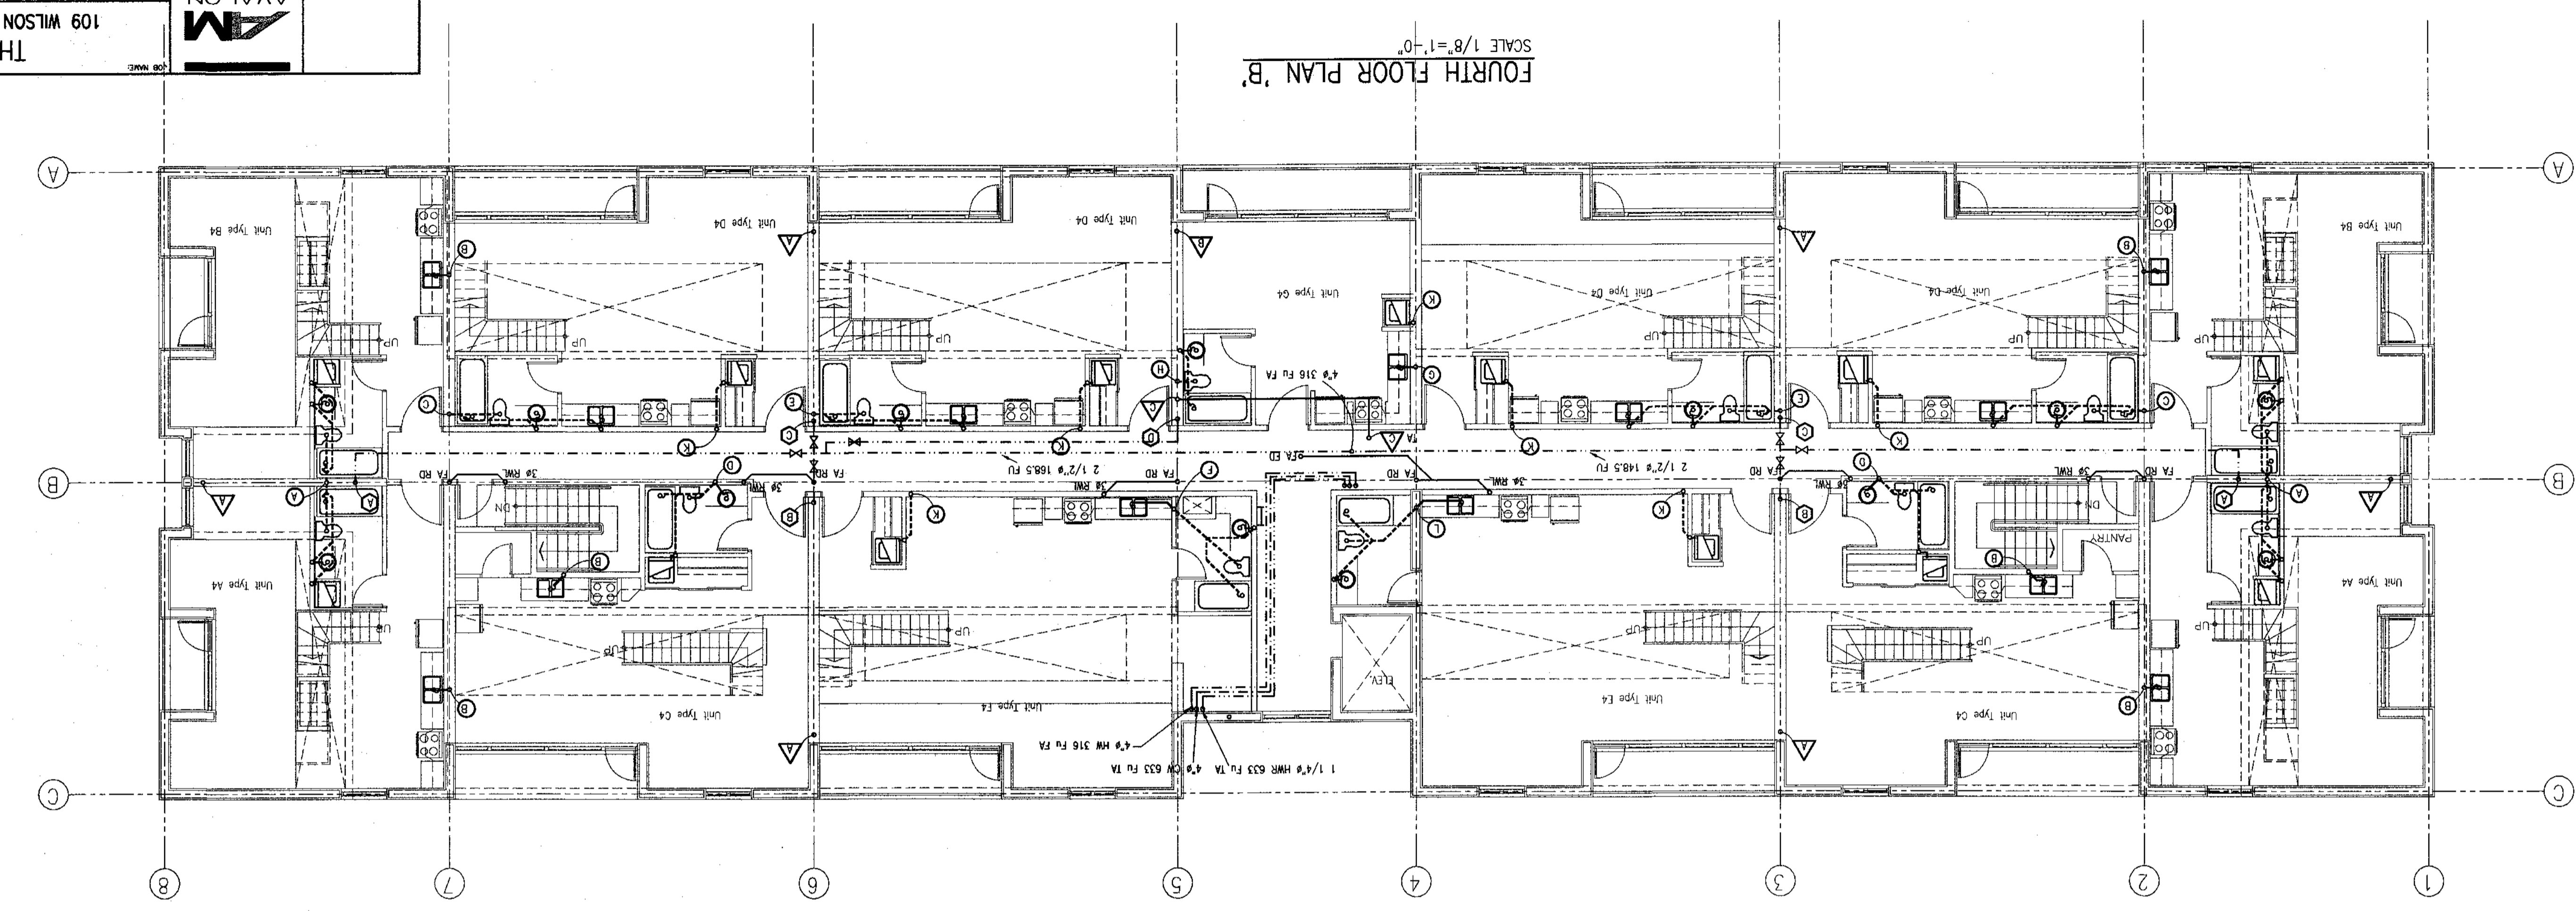

- LEGEND**
- V — VENT (IN CEILING SPACE)
 - PD — PERIMETER DRAIN (UNDERGROUND/FLOOR)
 - D — DRAIN (ABOVE FLOOR)
 - D — DRAIN (UNDERGROUND/FLOOR)
 - S — SEWER (ABOVE FLOOR)
 - S — SEWER (UNDERGROUND/FLOOR)
 - W — WATER (ABOVE FLOOR)
 - W — WATER (UNDERGROUND/FLOOR)
 - G — GAS (ABOVE FLOOR)
 - G — GAS (UNDERGROUND/FLOOR)
 - ▲— HEAT TRACE
 - ▲— GAS RISER
 - ▲— WATER RISER
 - ▲— SEWER STACK
 - ▲— WATER METER
 - ▲— VALVE
 - ▲— GLOBE VALVE
 - ▲— CW/HWT/HMR SIZES
 - ▲— AD
 - ▲— COLD WATER
 - ▲— DECK DRAIN
 - ▲— FROM ABOVE
 - ▲— FB
 - ▲— FLOOR DRAIN
 - ▲— HW
 - ▲— HOT WATER
 - ▲— HWR
 - ▲— HOT WATER RECIRCULATION
 - ▲— HWT
 - ▲— HOT WATER TANK
 - ▲— RD
 - ▲— ROOF DRAIN
 - ▲— RML
 - ▲— RAIN WATER LEADER
 - ▲— TA
 - ▲— TO ABOVE
 - ▲— TB
 - ▲— TO BELOW
 - ▲— WALL HYDRANT

FOURTH FLOOR PLAN 'B'
SCALE 1/8"=1'-0"

FOURTH FLOOR MEZZANINE PLAN 'B'
SCALE 1/8"=1'-0"