
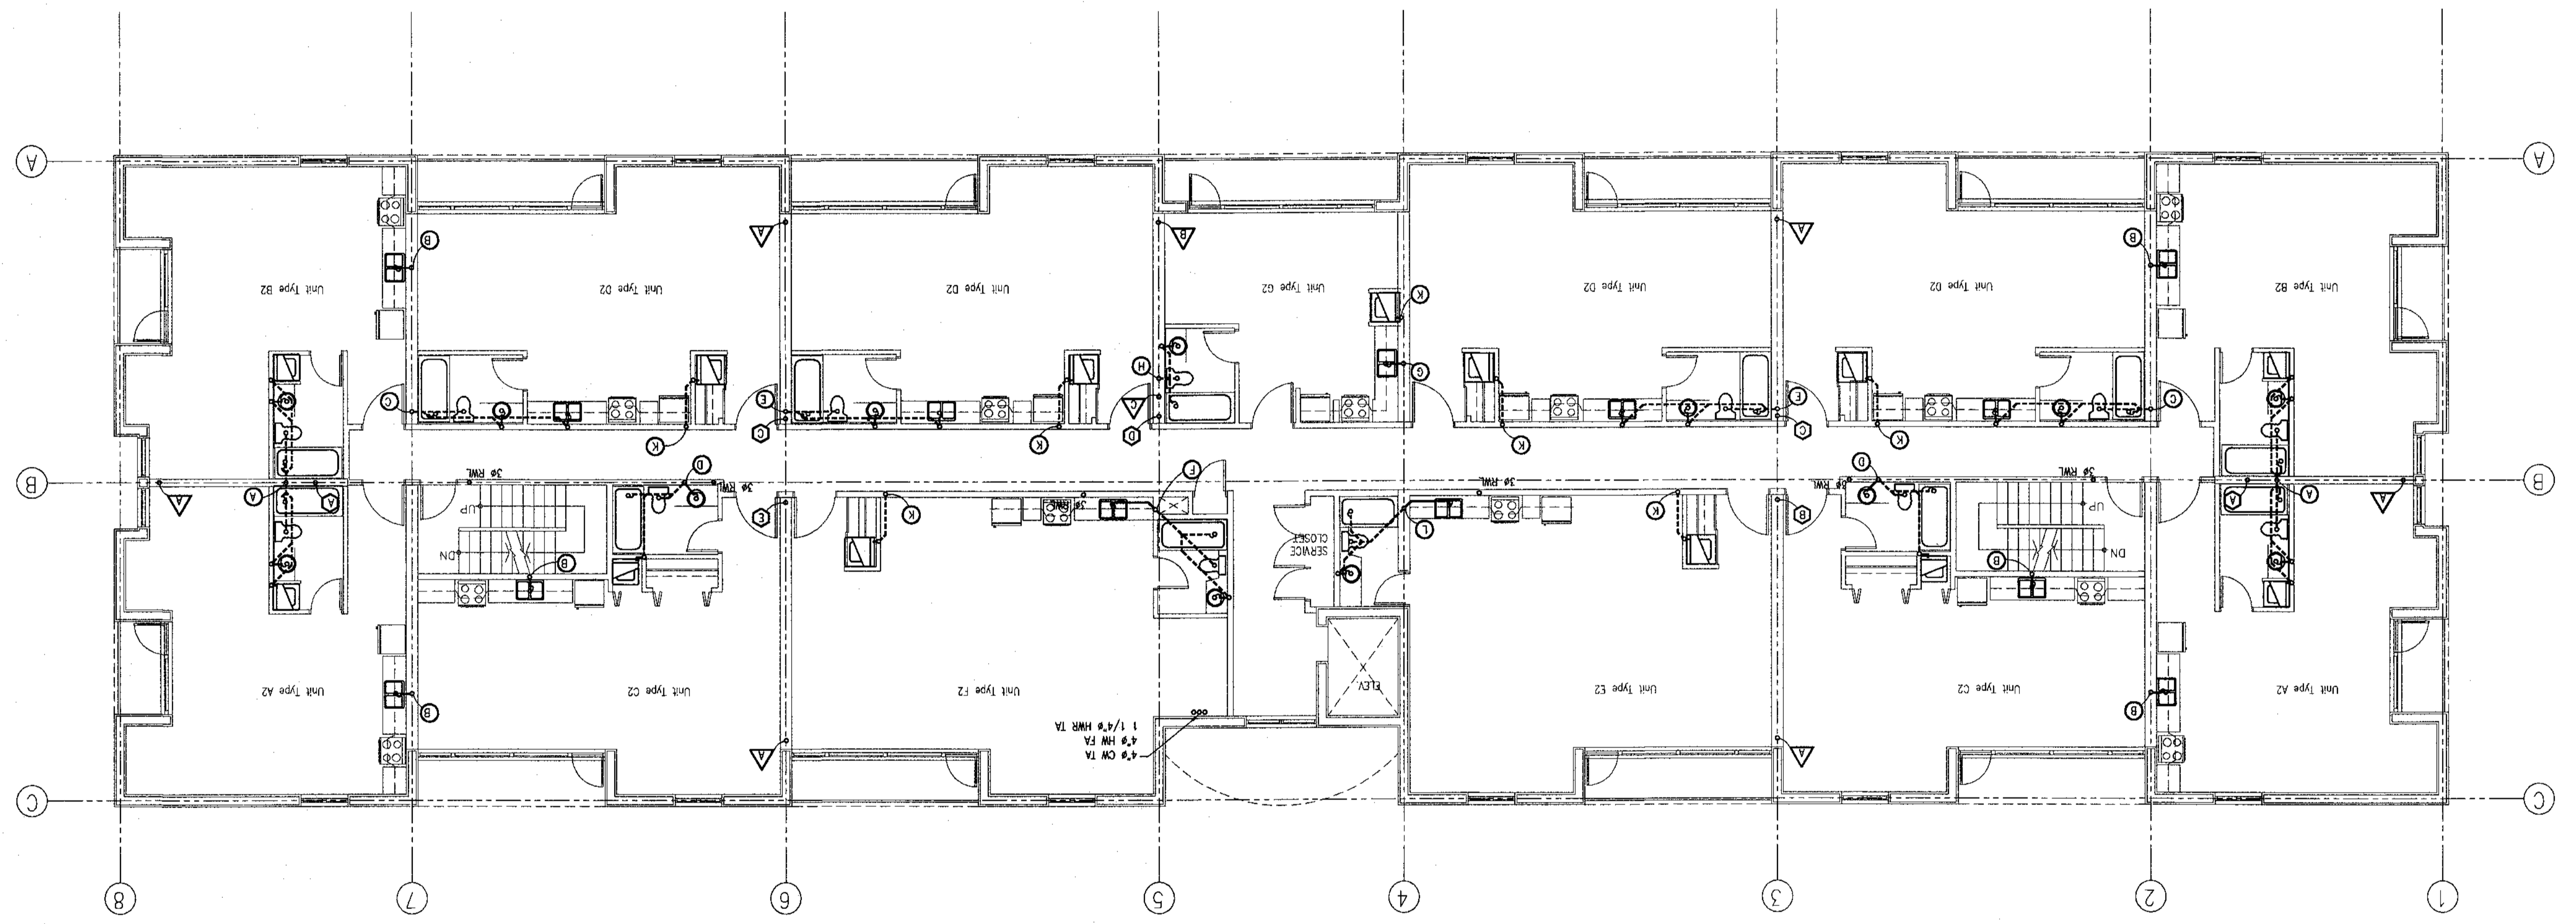


JOB NO.: 203079	DATE: (DDMMYY) 15OCT03	DRAWN BY: M.D.	CHECKED BY: J.E.	SCALE: AS NOTED	SHEET NO.: 5 OF 11	JOB NAME: THE WING 109 WILSON ST., VICTORIA, B.C.	SHEET TITLE: SECOND & THIRD FLOOR PLANS	 AVALON MECHANICAL CONSULTANTS LTD. #1 1224 GARDINER STREET VICTORIA, B.C. V8W 2E8 TEL: 251-1124 FAX: 251-1124

NO.	DATE (DDMMYY)	DESCRIPTION
1	04NOV03	ISSUED FOR BUILDING PERMIT

NOTES:
 1. SITE VERIFY EXISTING PIPING, EQUIPMENT, ETC.
 2. ALL 6" SEWER & STORM LINES ARE AT A MINIMUM 0.75% SLOPE, ALL 4" SEWER & STORM LINES ARE AT A MINIMUM 1% SLOPE, AND ALL 3" LINES ARE AT A MINIMUM 2% SLOPE UNLESS OTHERWISE INDICATED.
 3. ALL GAS LINES SCHEDULE 40 @ 2 PSIG +/- 1 PSIG AND @ 1/2" UNLESS OTHERWISE INDICATED.

SECOND & THIRD FLOOR PLANS 'B'
 SCALE 1/8"=1'-0"



LEGEND

---V---	VENT (IN CEILING SPACE)
---PD---	PERIMETER DRAIN (UNDERGROUND/FLOOR)
-----D-----	DRAIN (ABOVE FLOOR)
-----D-----	DRAIN (UNDERGROUND/FLOOR)
-----S-----	SEWER (ABOVE FLOOR)
-----S-----	SEWER (UNDERGROUND/FLOOR)
-----W-----	WATER (ABOVE FLOOR)
-----W-----	WATER (UNDERGROUND/FLOOR)
-----G-----	GAS (ABOVE FLOOR)
-----G-----	GAS (UNDERGROUND/FLOOR)
~~~~~	HEAT TRACE
▲	GAS RISER
⊕	WATER RISER
⊕	SEWER STACK
⊕	WATER METER
⊕	VALVE
⊕	GLOBE VALVE
1"Ø 1/2" CW 1/2" HW 1/2" HW	AREA DRAIN
CW	COLD WATER
FA	FROM ABOVE
FB	FROM BELOW
RD	ROOF DRAIN
RWL	RAIN WATER LEADER
TA	TO ABOVE
TB	TO BELOW